




D
C
B
A

1

2

3

4

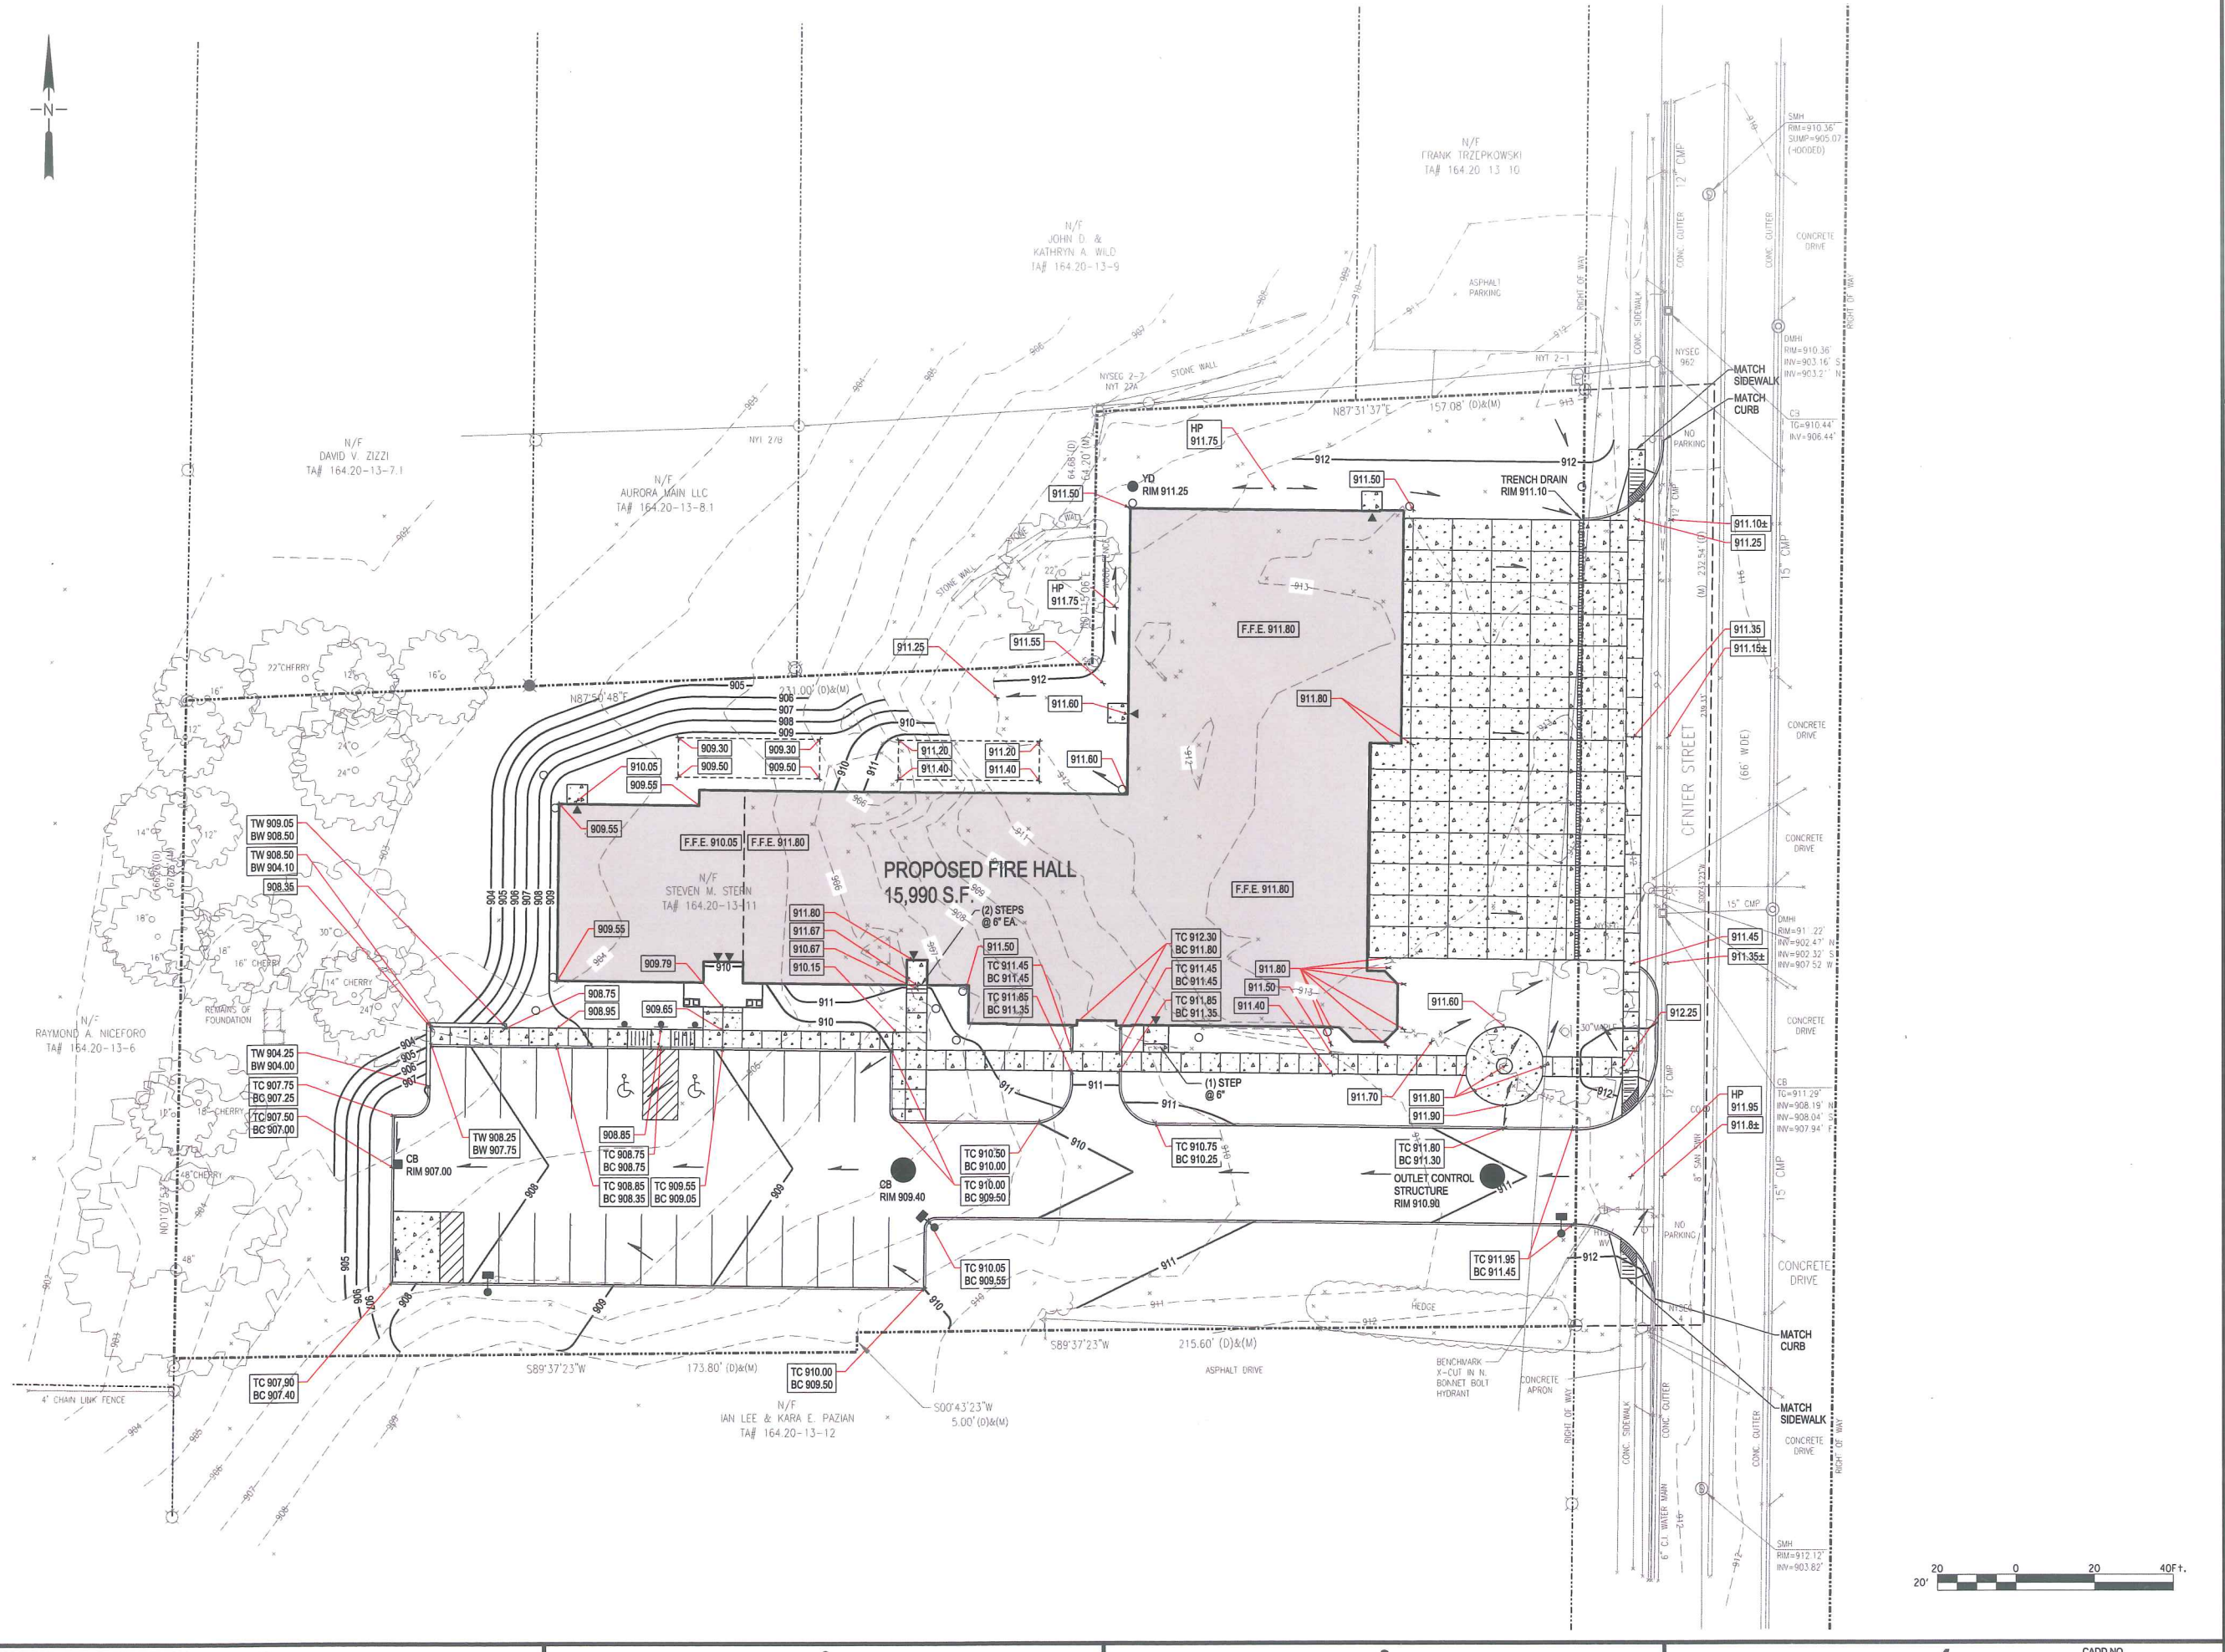

CADD NO.



C&S Engineers, Inc.
90 Broadway
Buffalo, New York 14203
Phone: 716-847-1630
Fax: 716-847-1454
www.cscos.com

D
C
B
A

EAST AURORA FIRE HALL
CENTER STREET
EAST AURORA, NY

MARK	DATE	DESCRIPTION
REVISIONS		
PROJECT NO: M50.001.001		
DATE:		
SCALE: AS NOTED		
DRAWN BY:		
DESIGNED BY:		
CHECKED BY:		
NO ALTERATION PERMITTED HEREON EXCEPT AS PROVIDED UNDER SECTION 7209 SUBDIVISION 2 OF THE NEW YORK EDUCATION LAW		

CIVIL
GRADING PLAN

C103

DATE
TIME